


排練室3 Rehearsal Room 3

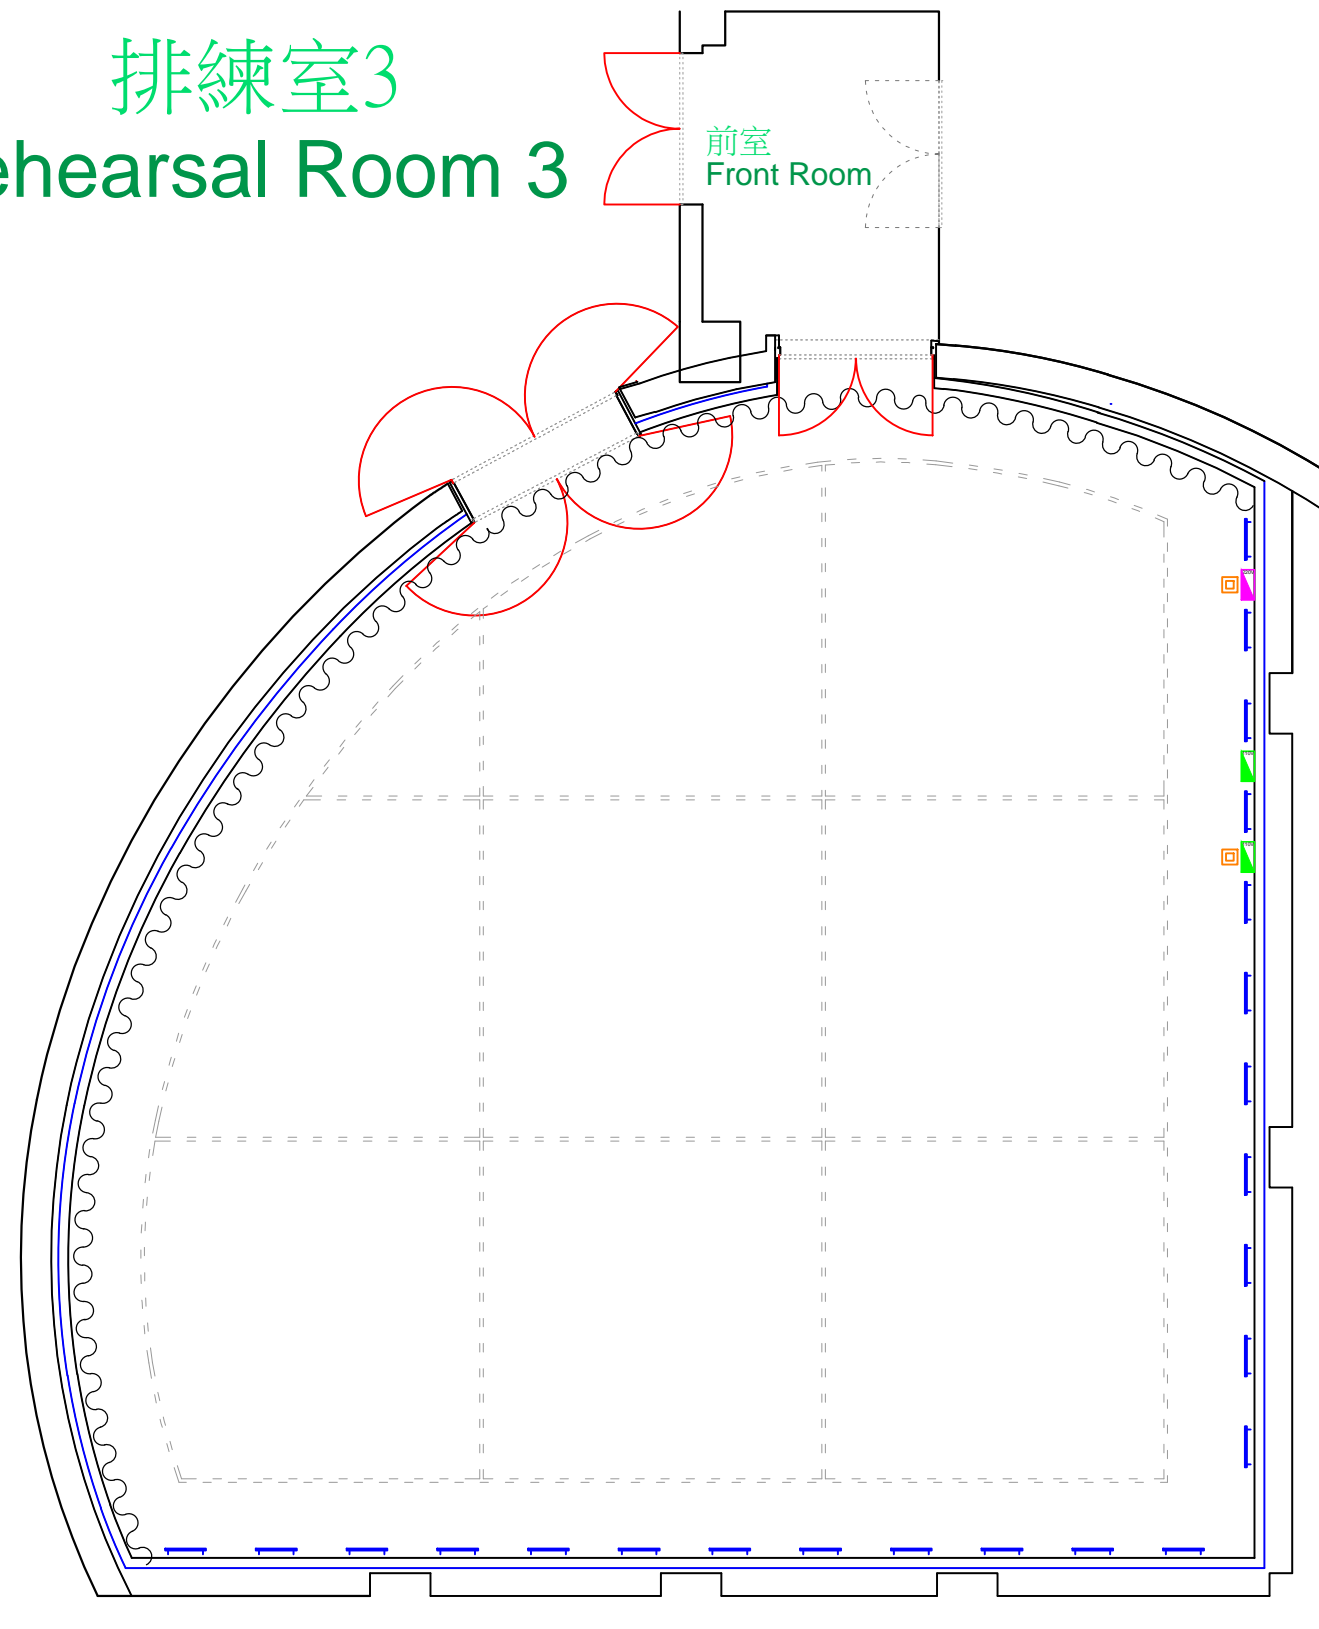

KEY	
	110V電源箱
	220V電源箱
	燈光、音響設備訊號箱

臺中國家歌劇院
NATIONAL
TAICHUNG
THEATER
三劇場共用空間
COMMON
SPACE

PRODUCTION
DIRECTOR
DESIGNER
LIGHTING
SET UP
PERFORM
DRAWN BY
DATE
DRAWING TITLE 05-C-5 排練室3平面圖 05-C-5 Floor Plan of Rehearsal Room 3
SCALE : 1/100 For A3
DRAWING DATE 2016 / 5
PRINT DATE