
 


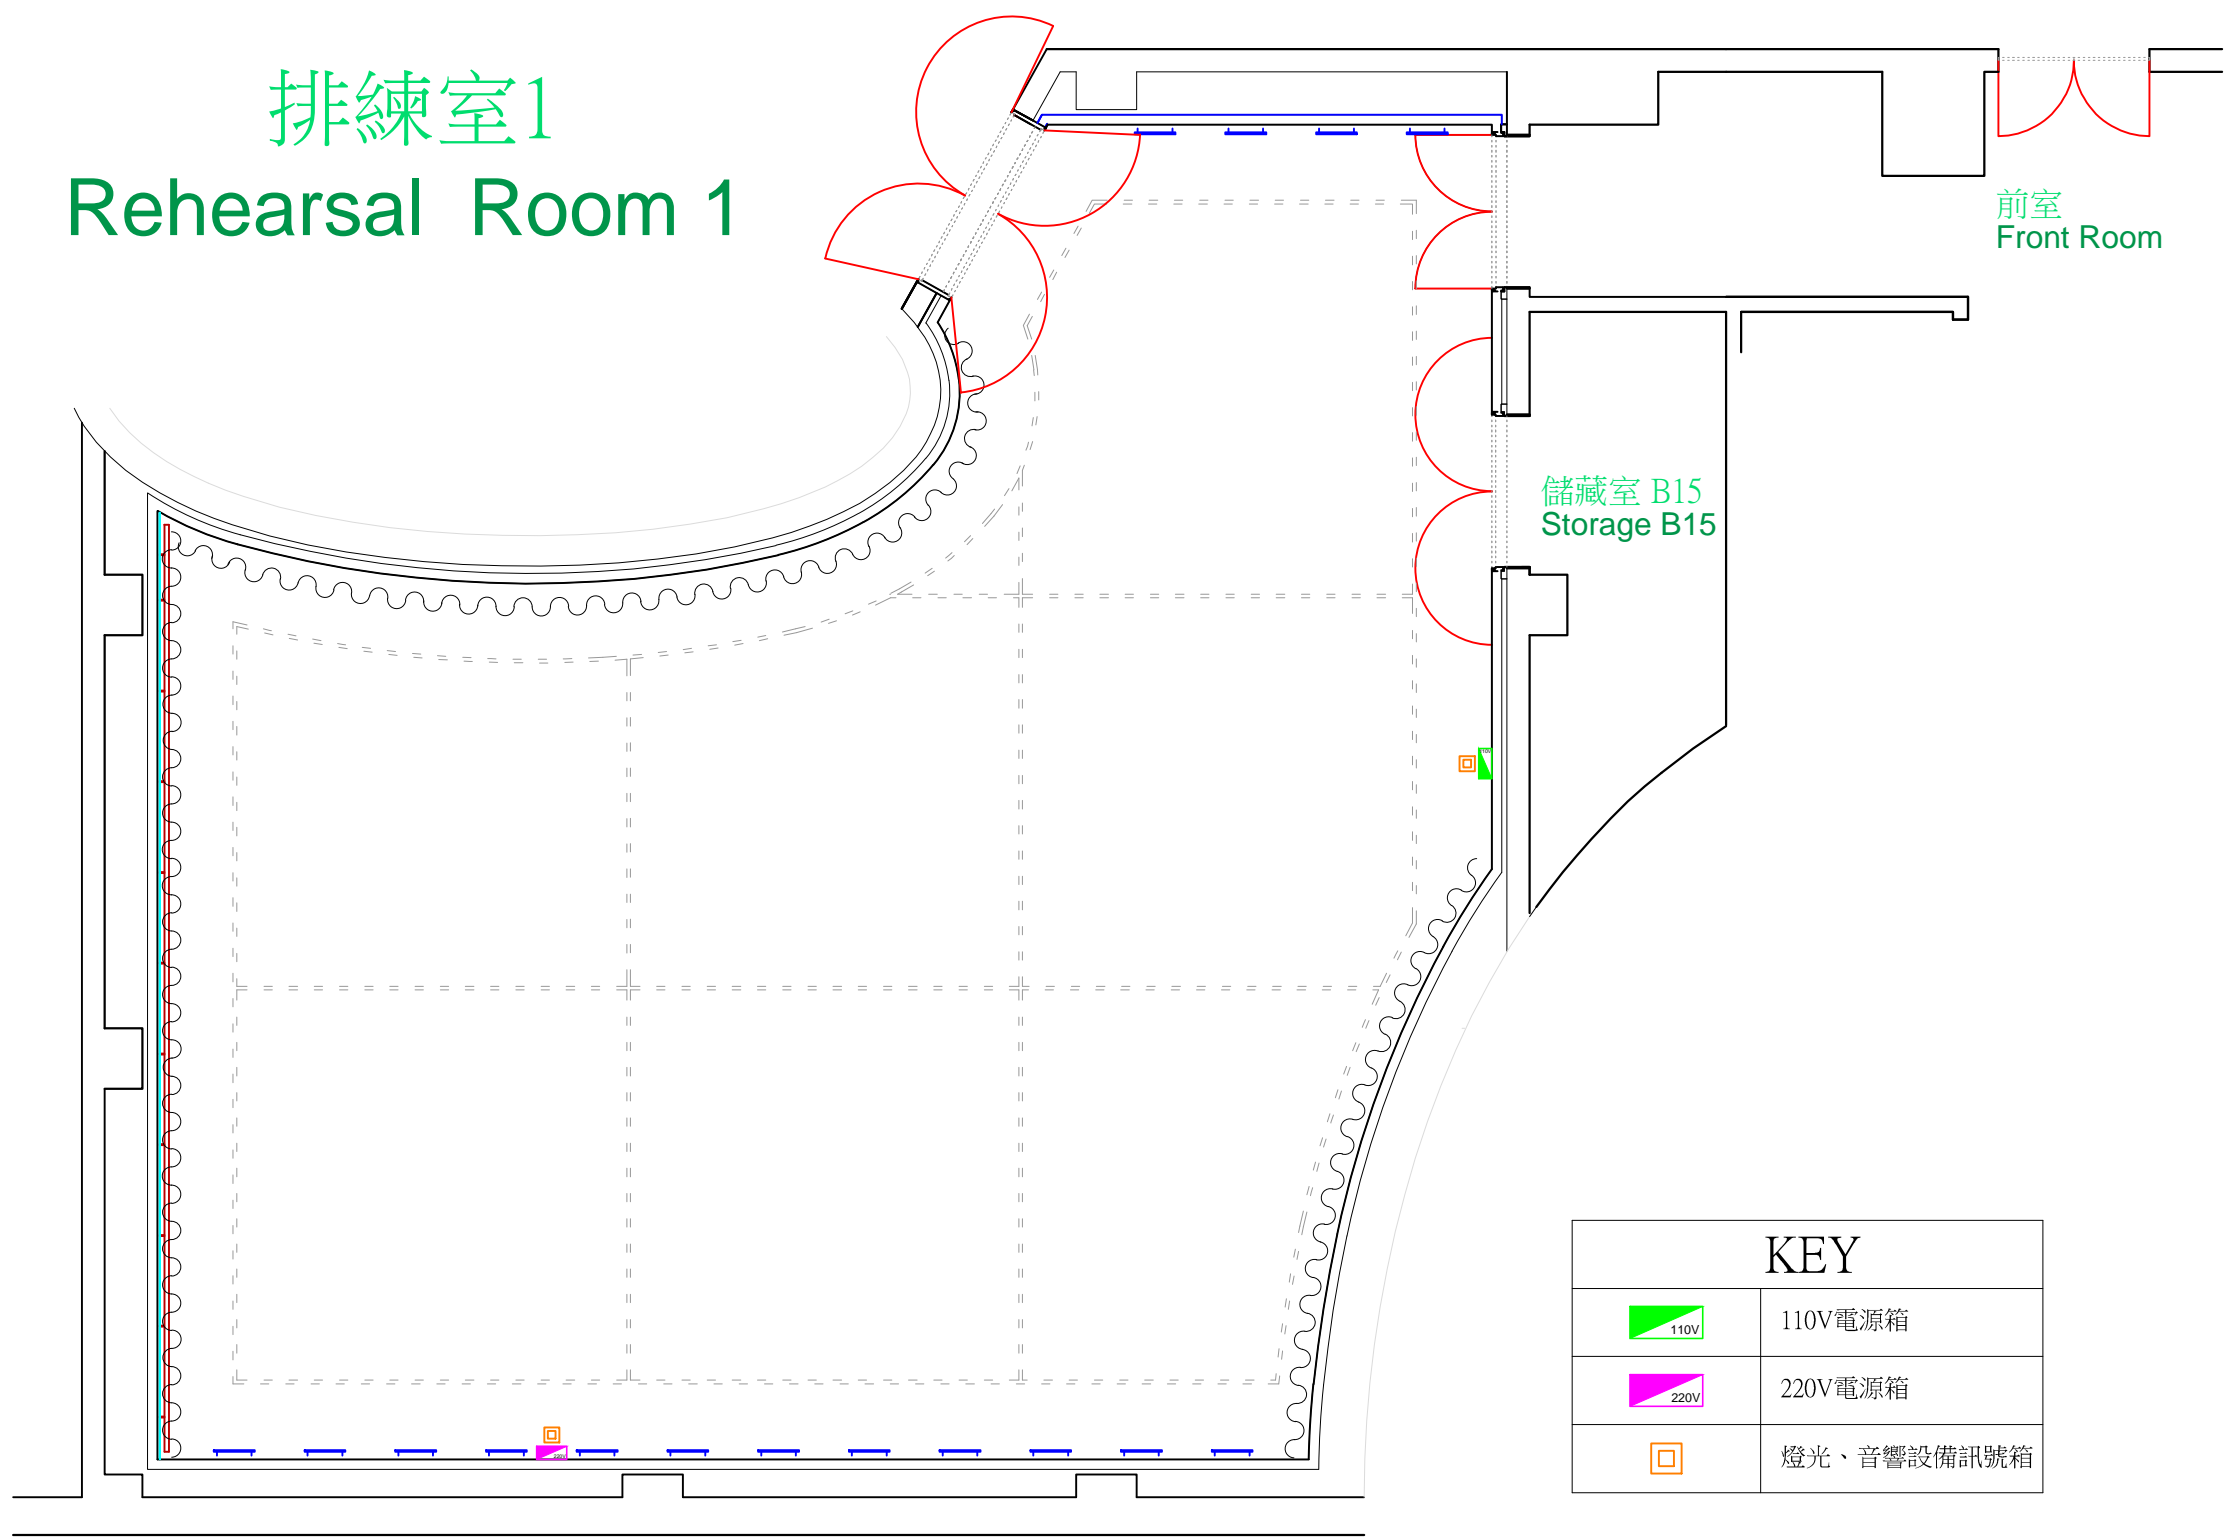

臺中國家歌劇院
 NATIONAL
 TAICHUNG
 THEATER
 三劇場共用空間
 COMMON
 SPACE

排練室1
 Rehearsal Room 1



KEY	
	110V電源箱
	220V電源箱
	燈光、音響設備訊號箱

PRODUCTION

DIRECTOR

DESIGNER

LIGHTING

SET UP

PERFORM

DRAWN BY

DATE

DRAWING TITLE
 03-C-3 排練室1平面圖
 03-C-3 Floor Plan of
 Rehearsal Room 1

SCALE : 1/100 For A3

DRAWING DATE
 2016 / 5

PRINT DATE