





臺中國家歌劇院  
 NATIONAL  
 TAICHUNG  
 THEATER  
 三劇場共用空間  
 COMMON  
 SPACE

排練室2  
 Rehearsal Room 2

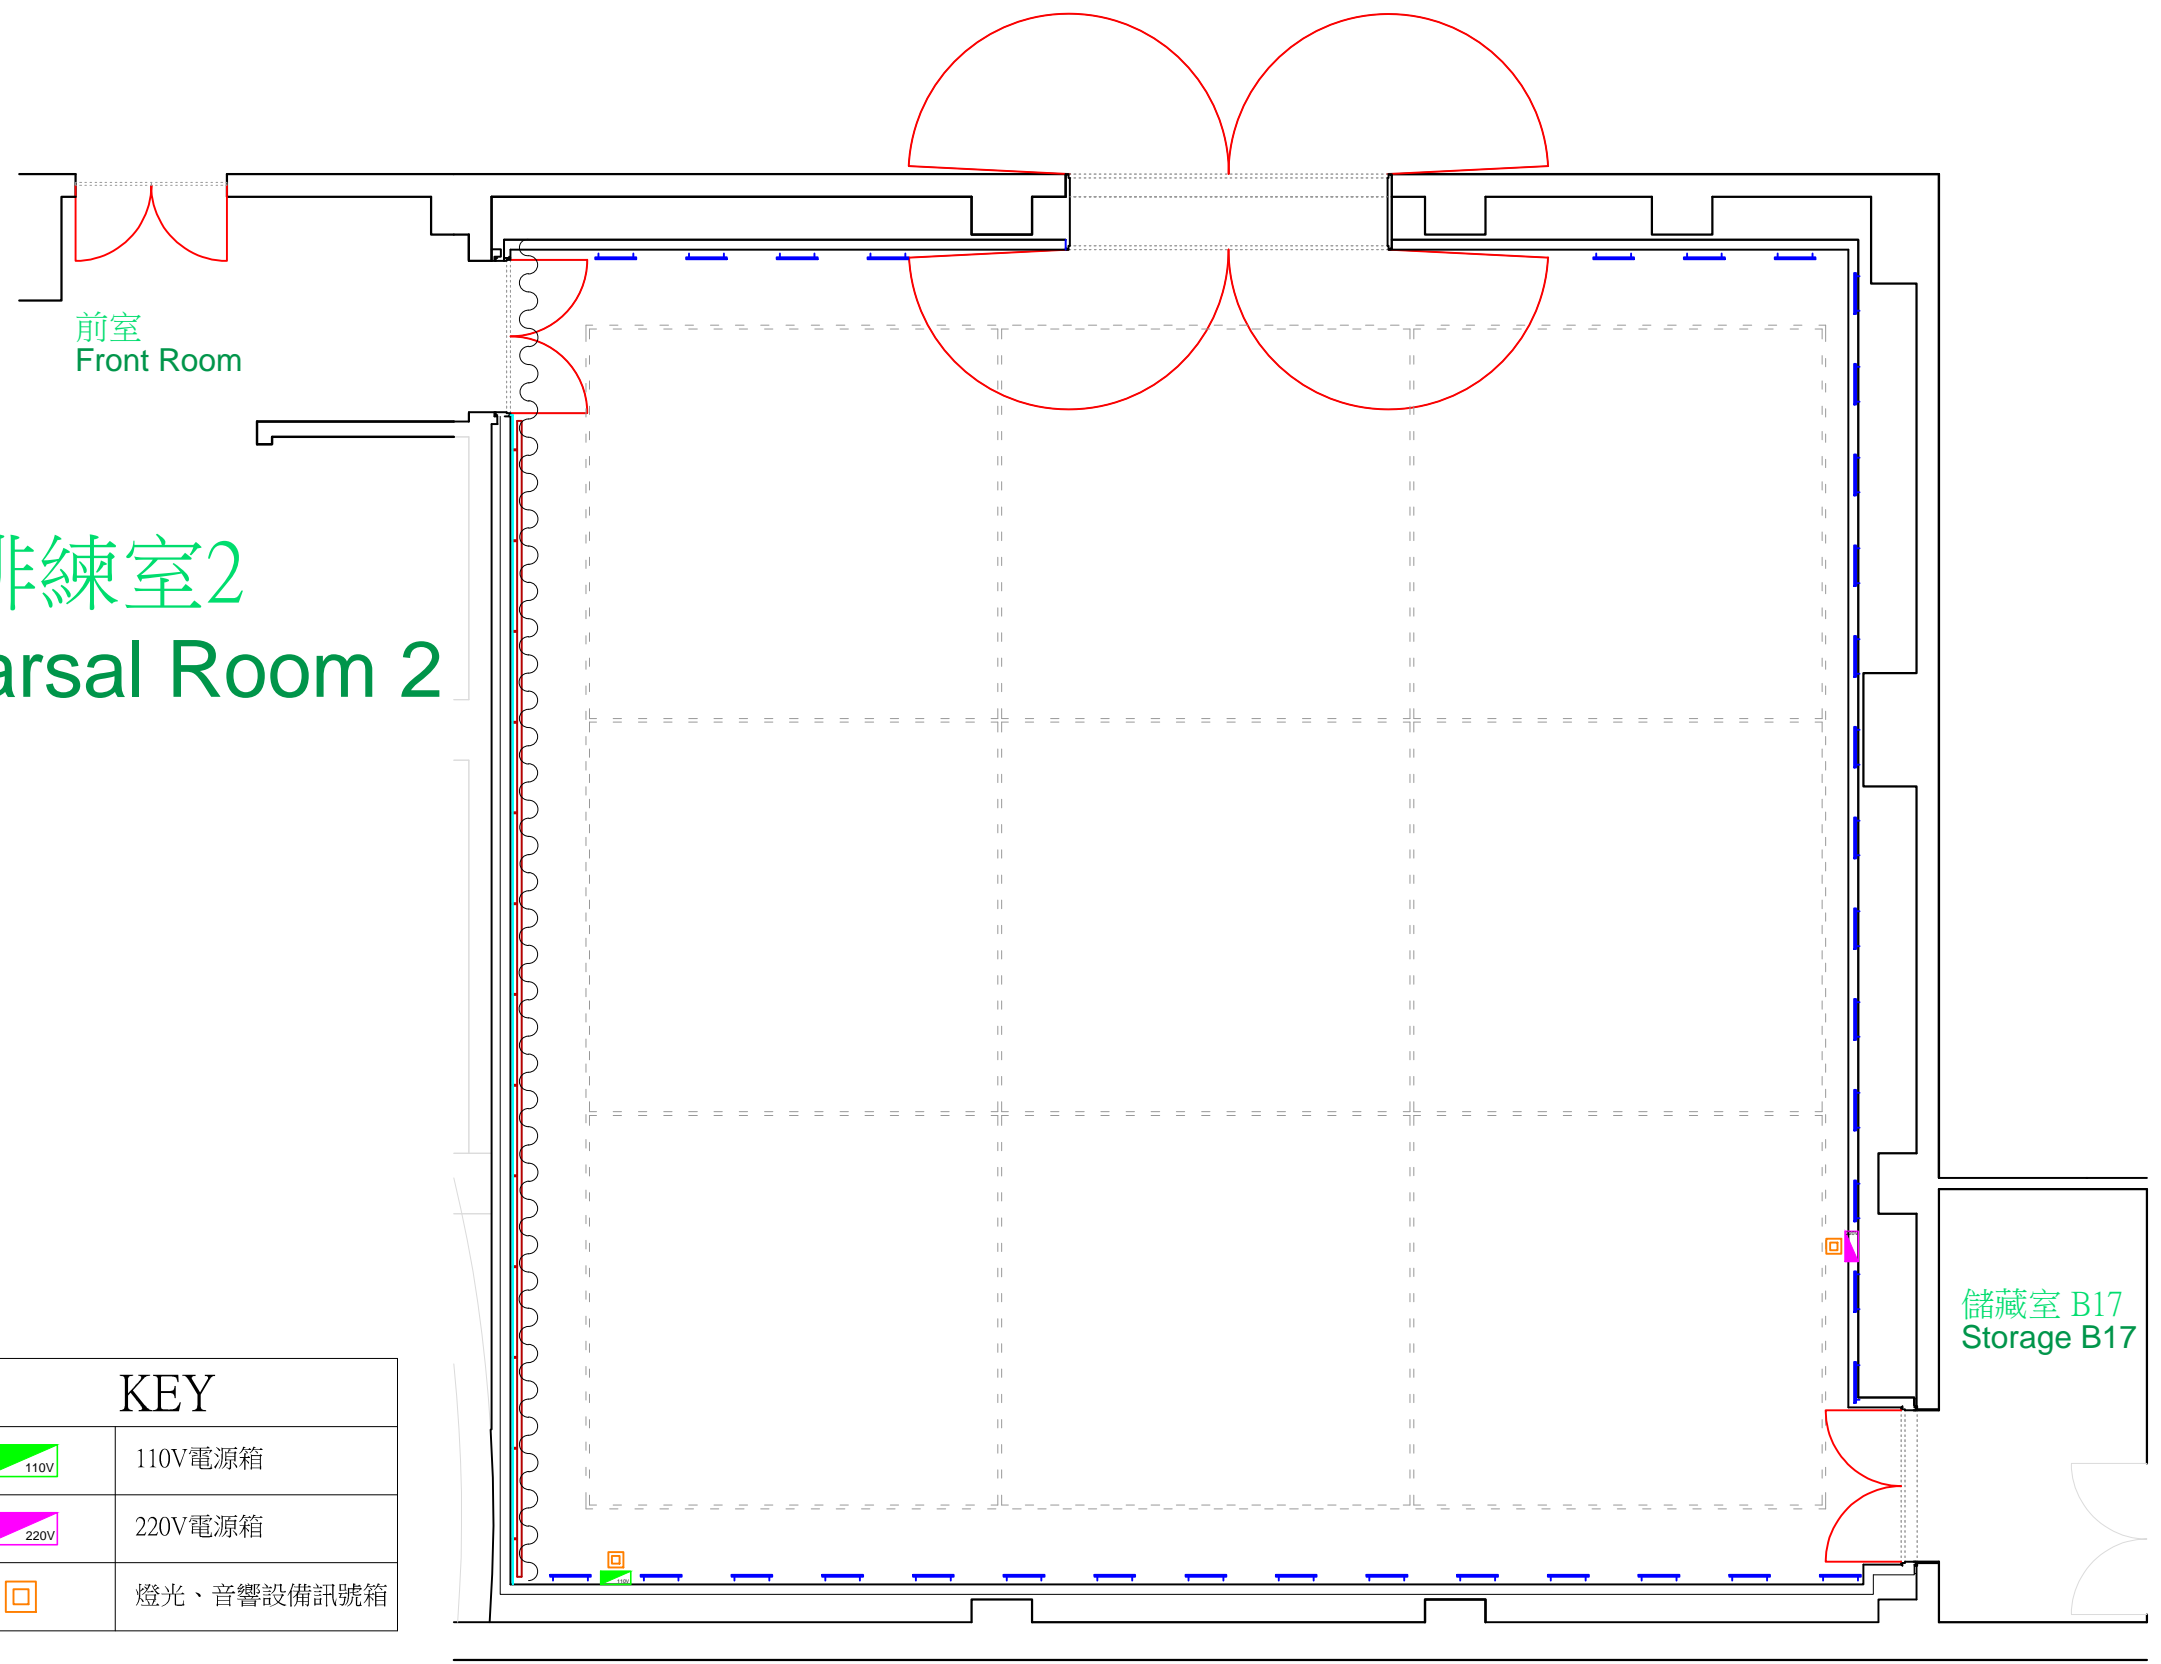

KEY	
	110V電源箱
	220V電源箱
	燈光、音響設備訊號箱

PRODUCTION

DIRECTOR

DESIGNER

LIGHTING

SET UP

PERFORM

DRAWN BY

DATE

DRAWING TITLE

04-C-4 排練室2平面圖  
 04-C-4 Floor Plan of  
 Rehearsal Room 2

SCALE : 1/100 For A3

DRAWING DATE

2016 / 5

PRINT DATE