


臺中國家歌劇院  
 NATIONAL  
 TAICHUNG  
 THEATER  
 三劇場共用空間  
 COMMON  
 SPACE

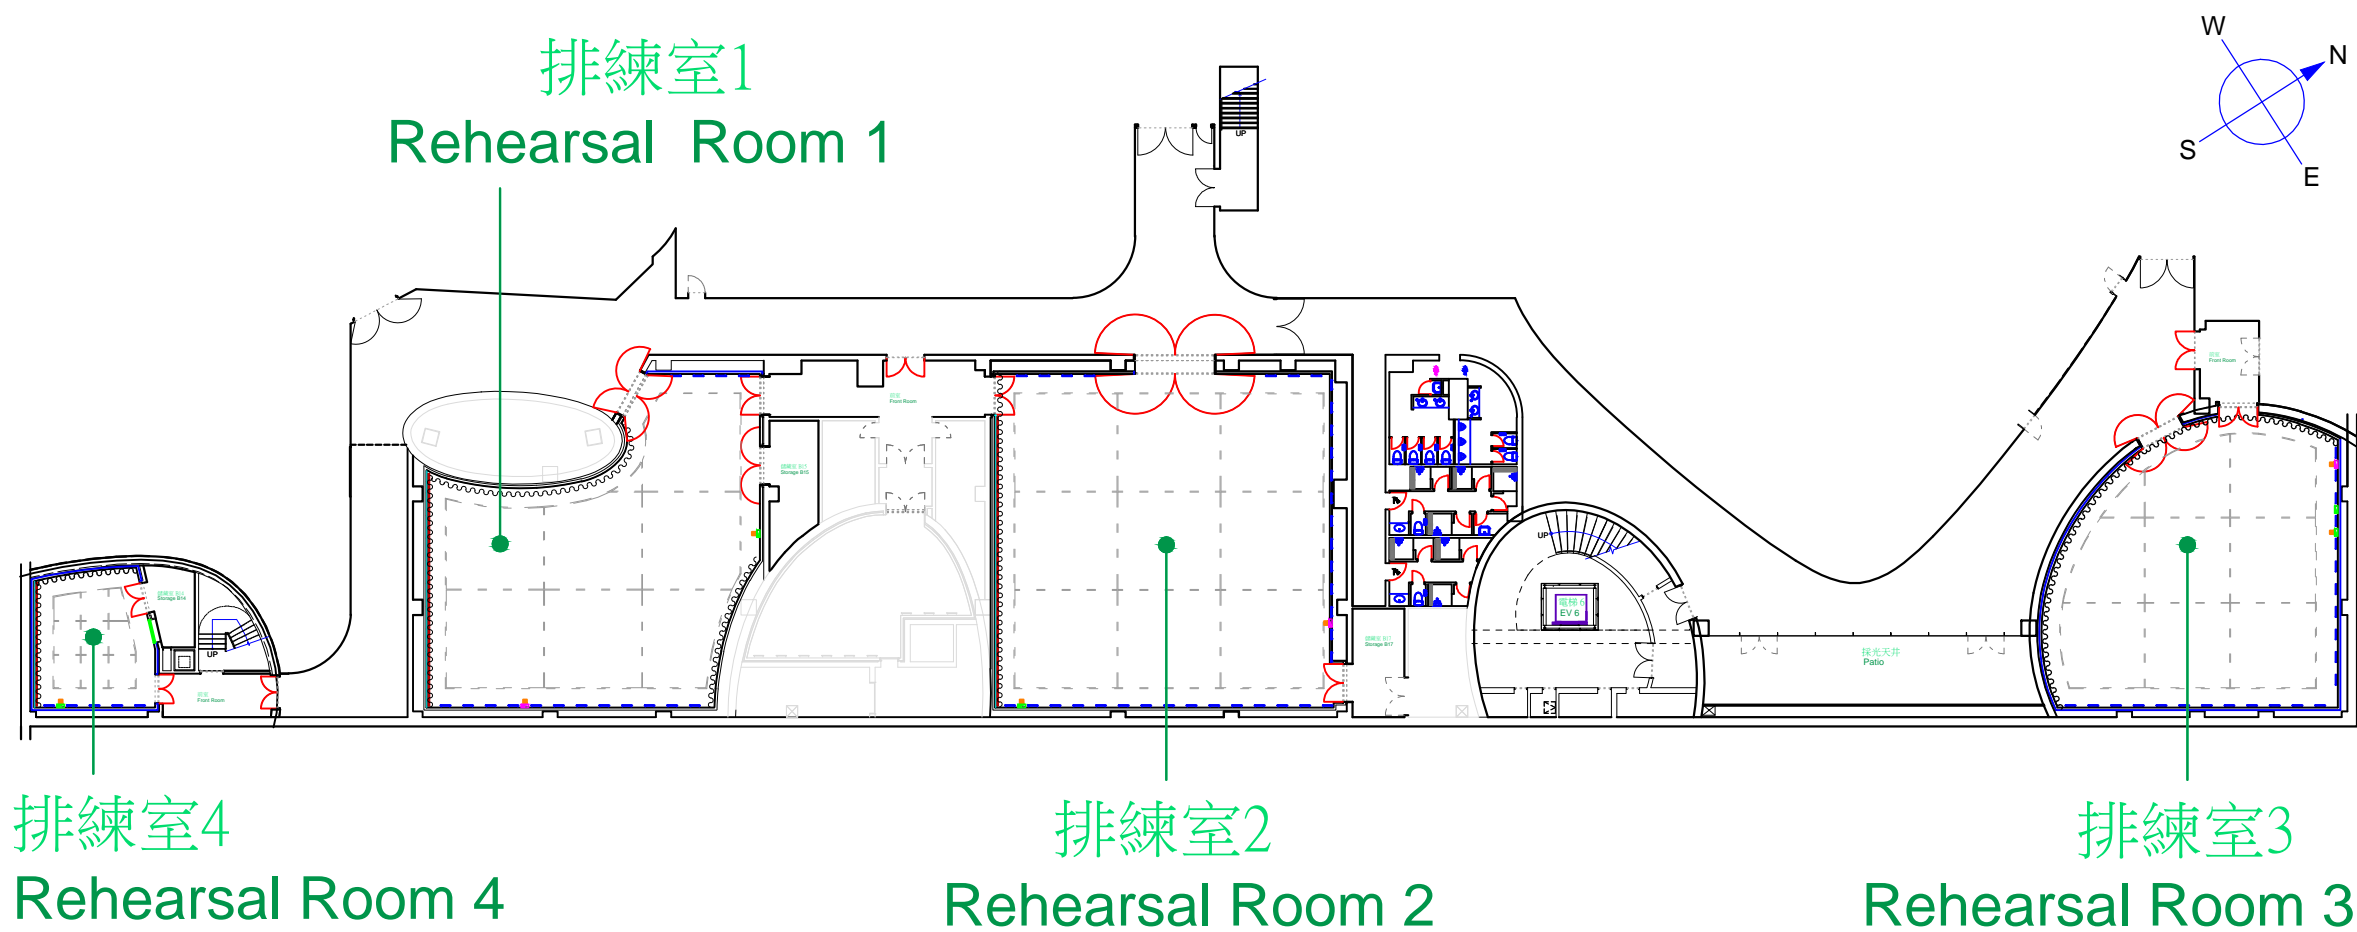

PRODUCTION

DIRECTOR

DESIGNER

LIGHTING

SET UP

PERFORM

DRAWN BY

DATE

DRAWING TITLE

02-C-2 排練室平面圖  
 02-C-2 Floor Plan of  
 Rehearsal Rooms

SCALE : 1/400 For A3

DRAWING DATE

2016 / 5

PRINT DATE