


# 排練室4

## Rehearsal room 4

臺中國家歌劇院  
 NATIONAL  
 TAICHUNG  
 THEATER  
 三劇場共用空間  
 COMMON  
 SPACE

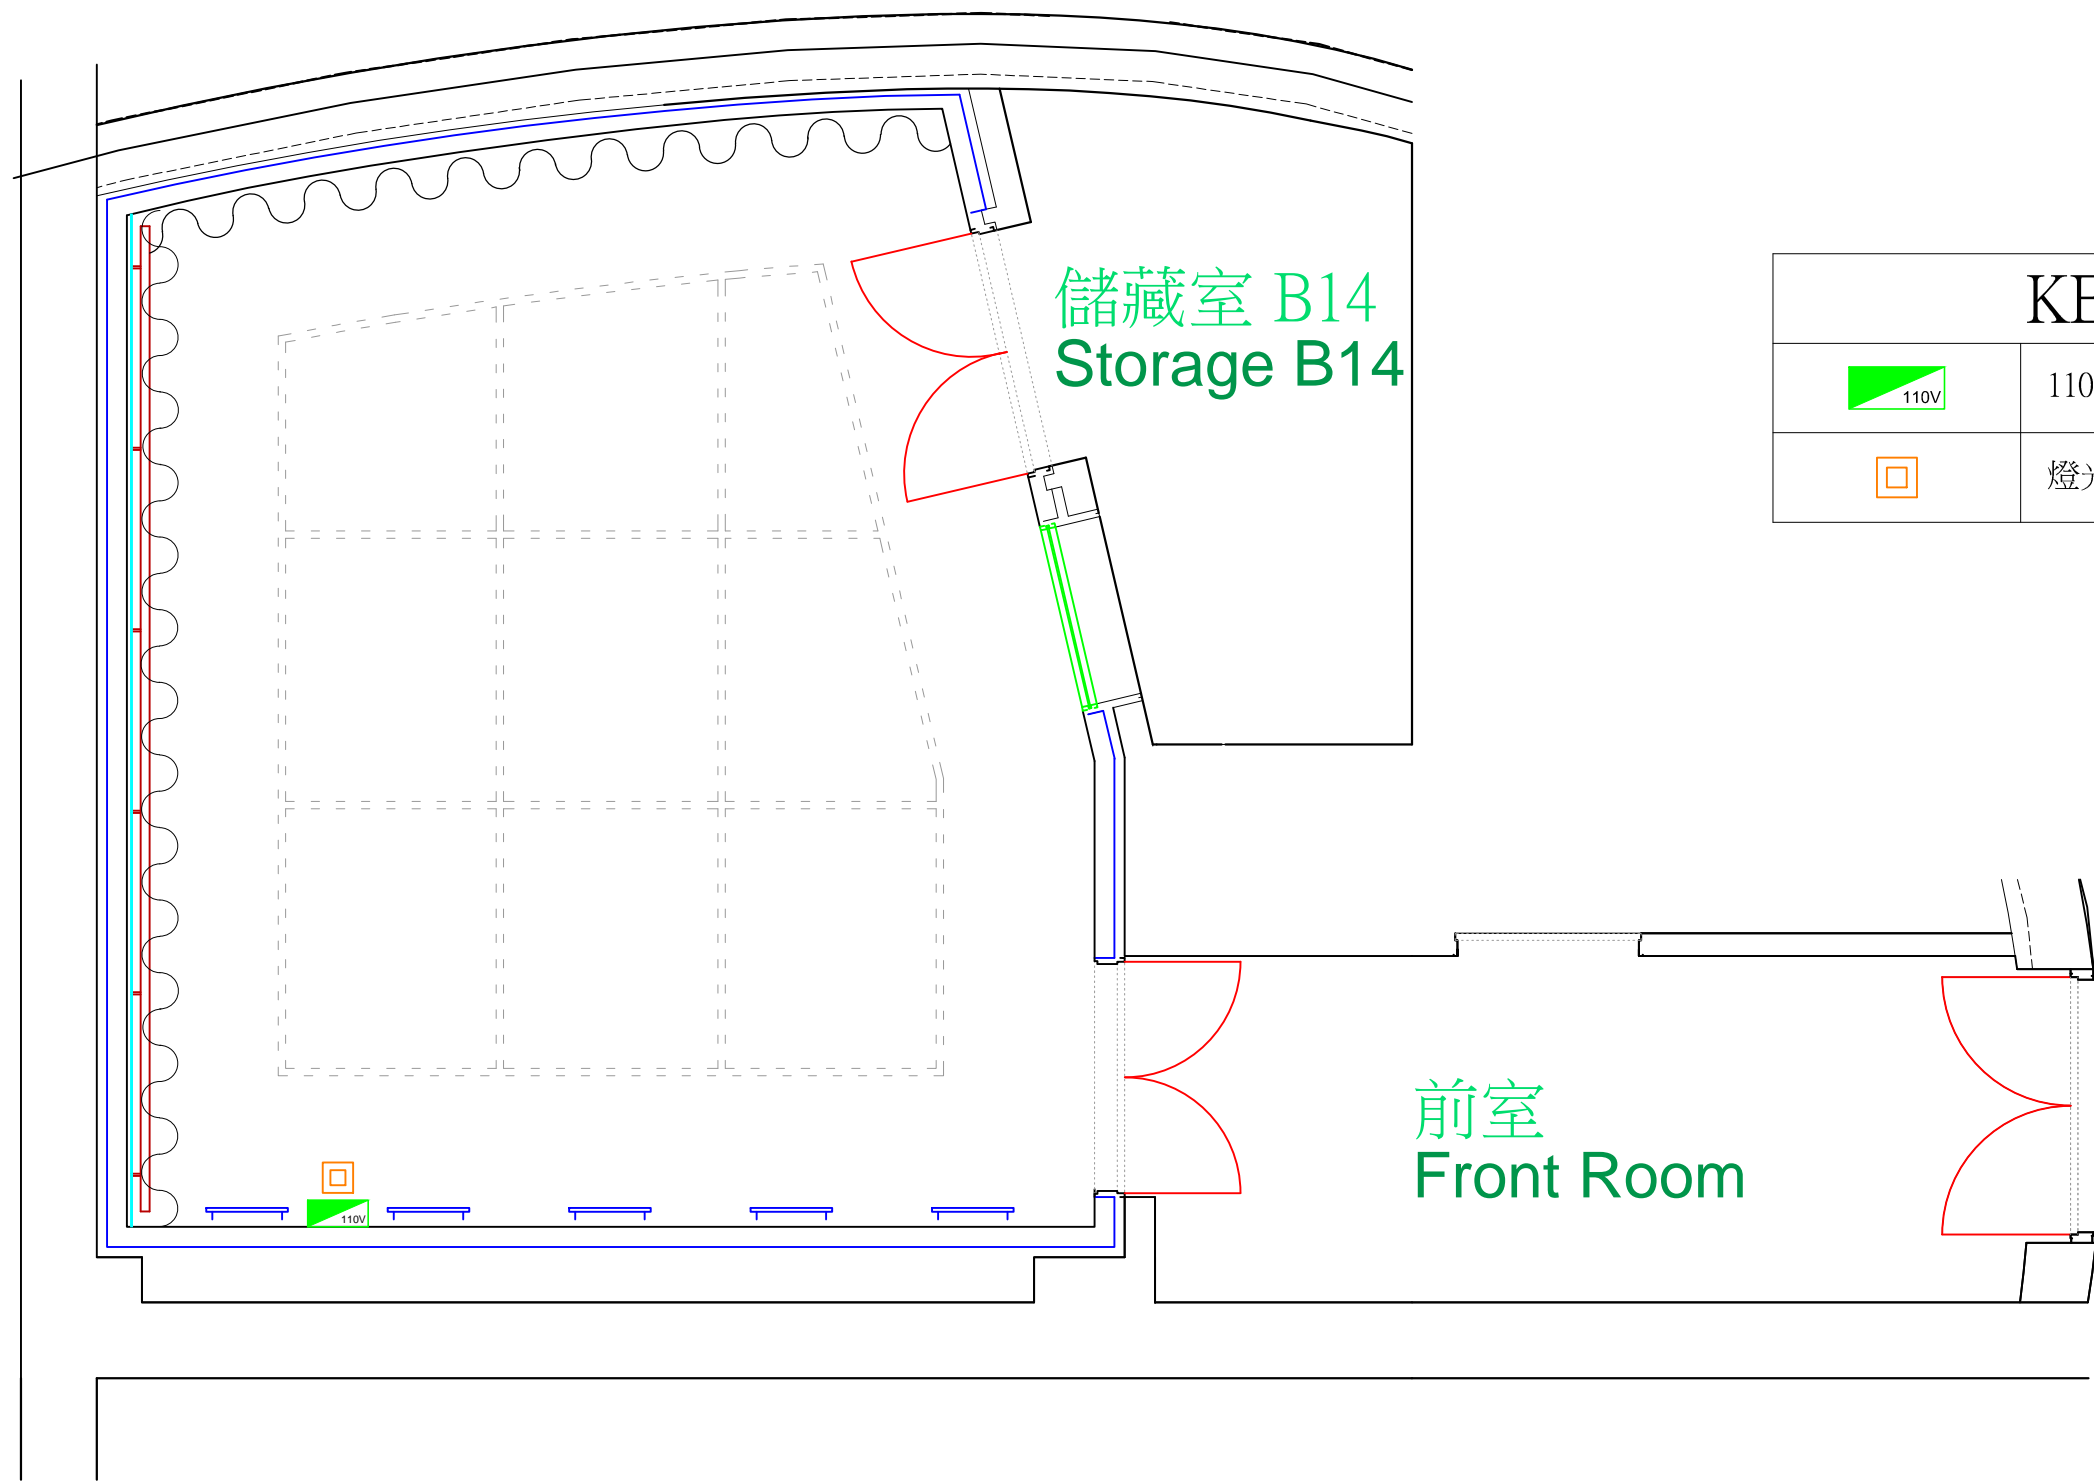

KEY	
	110V電源箱
	燈光、音響設備訊號箱

PRODUCTION
DIRECTOR
DESIGNER
LIGHTING
SET UP
PERFORM
DRAWN BY
DATE
DRAWING TITLE
06-C-6 排練室4平面圖 06-C-6 Floor Plan of Rehearsal Room 4
SCALE : 1/50 For A3
DRAWING DATE
2016 / 5
PRINT DATE